

NOTE — INTERPRET ALL DRAWINGS IN ACCORDANCE WITH ANSI Y14.5-1982

1 REMOVE ALL SHARP EDGES

3/4 HANGING CLOSET w/DRAWER STORAGE BELOW & SAFE MOUNTED INSIDE

CUSTOM ETCHED DIVIDER WALL w/ ROPE LIGHTING & PRIVACY SHADE

FANTASTIC FAN

SHOWER w/CADDY, SEAT & HAND HELD TEMPERATURE CONTROLLED SHOWER HEAD

CRUISAIR EBS16 EVAPORATOR & PLUMBING STACK

PULL-OUT PANTRY w/FWD. FACING RECESS FOR ART, INBOARD GRILLE #3630036 FOR AIR RETURN, CRUISAIR ACCESS DOORS, POCKET DOOR SWITCH & ELECTRIC HEATER BELOW

ABOVE DINETTE STORAGE CAB. w/CHANDELIER & FWD. DISPLAY

MOTORIZED J-SHAPED DINETTE

SOFA END TABLE

ELECTRIC SLEEPER SOFA w/SUBWOOFER BELOW

SALON TABLE w/DVD RECORDER, VCR, BOSE HEAD UNIT, A/B SWITCH, AQUA-HOT T-STAT, INTERNET SATELITE SYSTEM PREWIRE, CRUISAIR CONTROLLER, PHONE JACK, SLIDE OUT SWITCH & 12V ACCESSORY PLUG ON FWD. FACE, ELECTRIC HEATER & 110V OUTLET IN TOE KICK & CRUISAIR EBS16 EVAPORATOR BELOW

SALON STORAGE WITH DUCT AT CEILING

DRIVERS CONSOLE w/CUP HOLDER & CB RADIO

FLIP DOWN 42" LCD TV

SW6 & SW7 SWITCH PANELS ON DASH

SW8 SWITCH PANEL

FLUSH MOUNT GPS PASS. SIDE SCREEN ON SWIVEL

SW13 SWITCH PANEL

SALON TABLE w/LAP TOP PULL-OUT, DRAWER STORAGE, VGA CABLE & VGA SWITCH CONNECTION TO INETVU, PHONE JACK, SW3 SWITCH PANEL, TV ANTENNA CONTROLLER & TWO 110V ELECTRICAL OUTLETS IN TOE KICK

ETCHED GALLEY SPLASH GUARD w/FIBER OPTIC LIGHTING

UPPER GALLEY STORAGE CABINET

GALLEY BASE w/ELECTRIC COOK TOP & SINGLE BOWL SINK BOTH w/CORIAN COVERS, TIP-OUT SPONGE TRAY, INSTA-HOT, CUTLERY DRAWER & TRASH CAN HANGING BEHIND DOOR

ELECTRIC COOK TOP w/CORIAN COVER

MICROWAVE CABINET w/TAMBOUR DOOR

UPPER GALLEY STORAGE CABINET

CRUISAIR EBS16 EVAPORATOR

SPICE RACK

36" REFRIGERATOR w/CORIAN STORAGE & CRUISAIR RETURN AIR GRILLE BELOW

ANTI-SIPHON VALVE 43" ABOVE FLOOR

ELECTRIC POCKET DOOR

ELECTRIC POCKET DOOR MOTOR

PRIVATE LAV. VANITY w/FANTASTIC FAN SWITCH INSIDE & ELECTRIC HEATER BELOW

SW12 SWITCH PANEL ON OUTBOARD FACE OF MED. CABINET

PRIVATE LAV. MEDICINE CAB. w/110V OUTLET INSIDE & 110V OUTLET LOCATED UNDERNEATH

ELECTRIC POCKET DOOR

ELECTRIC POCKET DOOR MOTOR

DRAWER STORAGE w/AQUA-HOT HEATER BELOW

MEDICINE CAB. w/110V OUTLET & SLIDEOUT CONTROLLER INSIDE, NIGHTLIGHT & 110V OUTLET BELOW

MD. PANEL w/2 CRUISAIR CONTROLLERS & MEDARD OVER MDP PANEL

CRUISAIR EBS16 EVAPORATOR

FULL HIGH STORAGE CABINET w/ADJUSTABLE SHELVES

STACKED FRONT LOADING WASHER/DRYER w/ REMOVABLE SIDE PANEL FOR CRUISAIR ACCESS

WALK-IN FULL HIGH HANGING CLOSET w/ SHOE STORAGE BELOW

TWO ROPE LIGHT DIMMER SWITCHES MOUNTED ON CLOSET OUTBOARD WALL

DRAWER STORAGE CABINET w/DISPLAY CASE ABOVE

ELECTRIC POCKET DOOR MOTOR

ELECTRIC POCKET DOOR

DRAWER STORAGE w/POCKET DOOR SWITCH & A/V EQUIPMENT ABOVE & ELEC. HEATER BELOW

FULL HIGH STORAGE CABINET w/ADJUSTABLE SHELVING & POCKET DOOR MOTOR ACCESS PANEL

SW11 SWITCH PANEL & ALARM CLOCK

AFT NIGHT STAND w/GROMMET IN TOP & 110V OUTLET INSIDE & ON FACE


OVER BED STORAGE CABINET w/READING LIGHTS ON UNDERSIDE

KING BED FRAME w/STORAGE DRAWER BELOW

KING PLATFORM & MATTRESS w/SUBWOOFER BELOW

FWD NIGHT STAND w/GROMMET IN TOP & 110V OUTLET INSIDE & ON FACE

VIDEO INTERCOM, C.O. DETECTOR, AQUA-HOT T-STAT, CRUISAIR CONTROLS & SW1 SWITCH PANEL

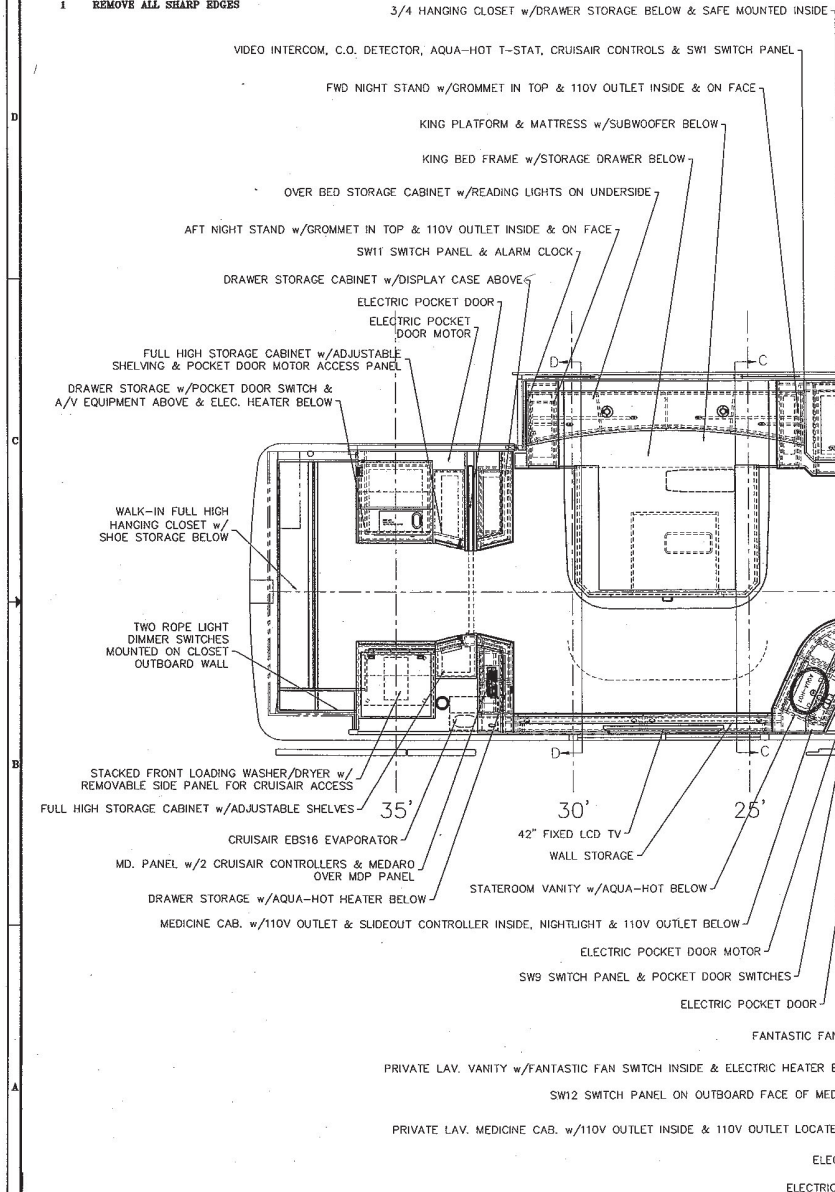

REV.	DESCRIPTION	DATE	APPROVAL
1			
2			
3			
4			

W. Milos
FEB 02 2007

HARDWARE BILL OF MATERIAL

CUSTOMER NAME: WINDERMERE
CUSTOMER APPROVAL & DATE:

DWG. BY <i>J. Milos</i>		1601 DOLINGER PL SANFORD FL 32771 TEL 1-407-568-1054 FAX 1-407-823-1945	
CHK. BY <i>MP</i>	ENGR. BY		
TITLE: FLOOR PLAN			
H3-S2		SCALE: NTS	DRAWING NO.: 06-0703-0011
DATE: 12/18/06		SHEET: 1 OF 1	REV: -
PROPRIETARY NOTICE: THIS DOCUMENT AND THE INFORMATION CONTAINED HEREIN ARE CONFIDENTIAL AND PROPRIETARY TO FEATHERLITE COACHES. NO PART OF THIS DOCUMENTATION IS TO BE REPRODUCED OR TRANSMITTED IN ANY FORM OR BY ANY MEANS, ELECTRONIC OR MECHANICAL, INCLUDING PHOTOCOPYING, RECORDING, OR BY ANY INFORMATION STORAGE AND RETRIEVAL SYSTEM, WITHOUT THE WRITTEN PERMISSION OF FEATHERLITE COACHES.			